






AAHAR - 2019

HALL A & B, GATE-1

MARCH 12-16, 2019


LEGEND :

-  EMERGENCY LIGHT
-  EMERGENCY EXIT
-  MANUAL CALL POINT
-  HOSE REEL

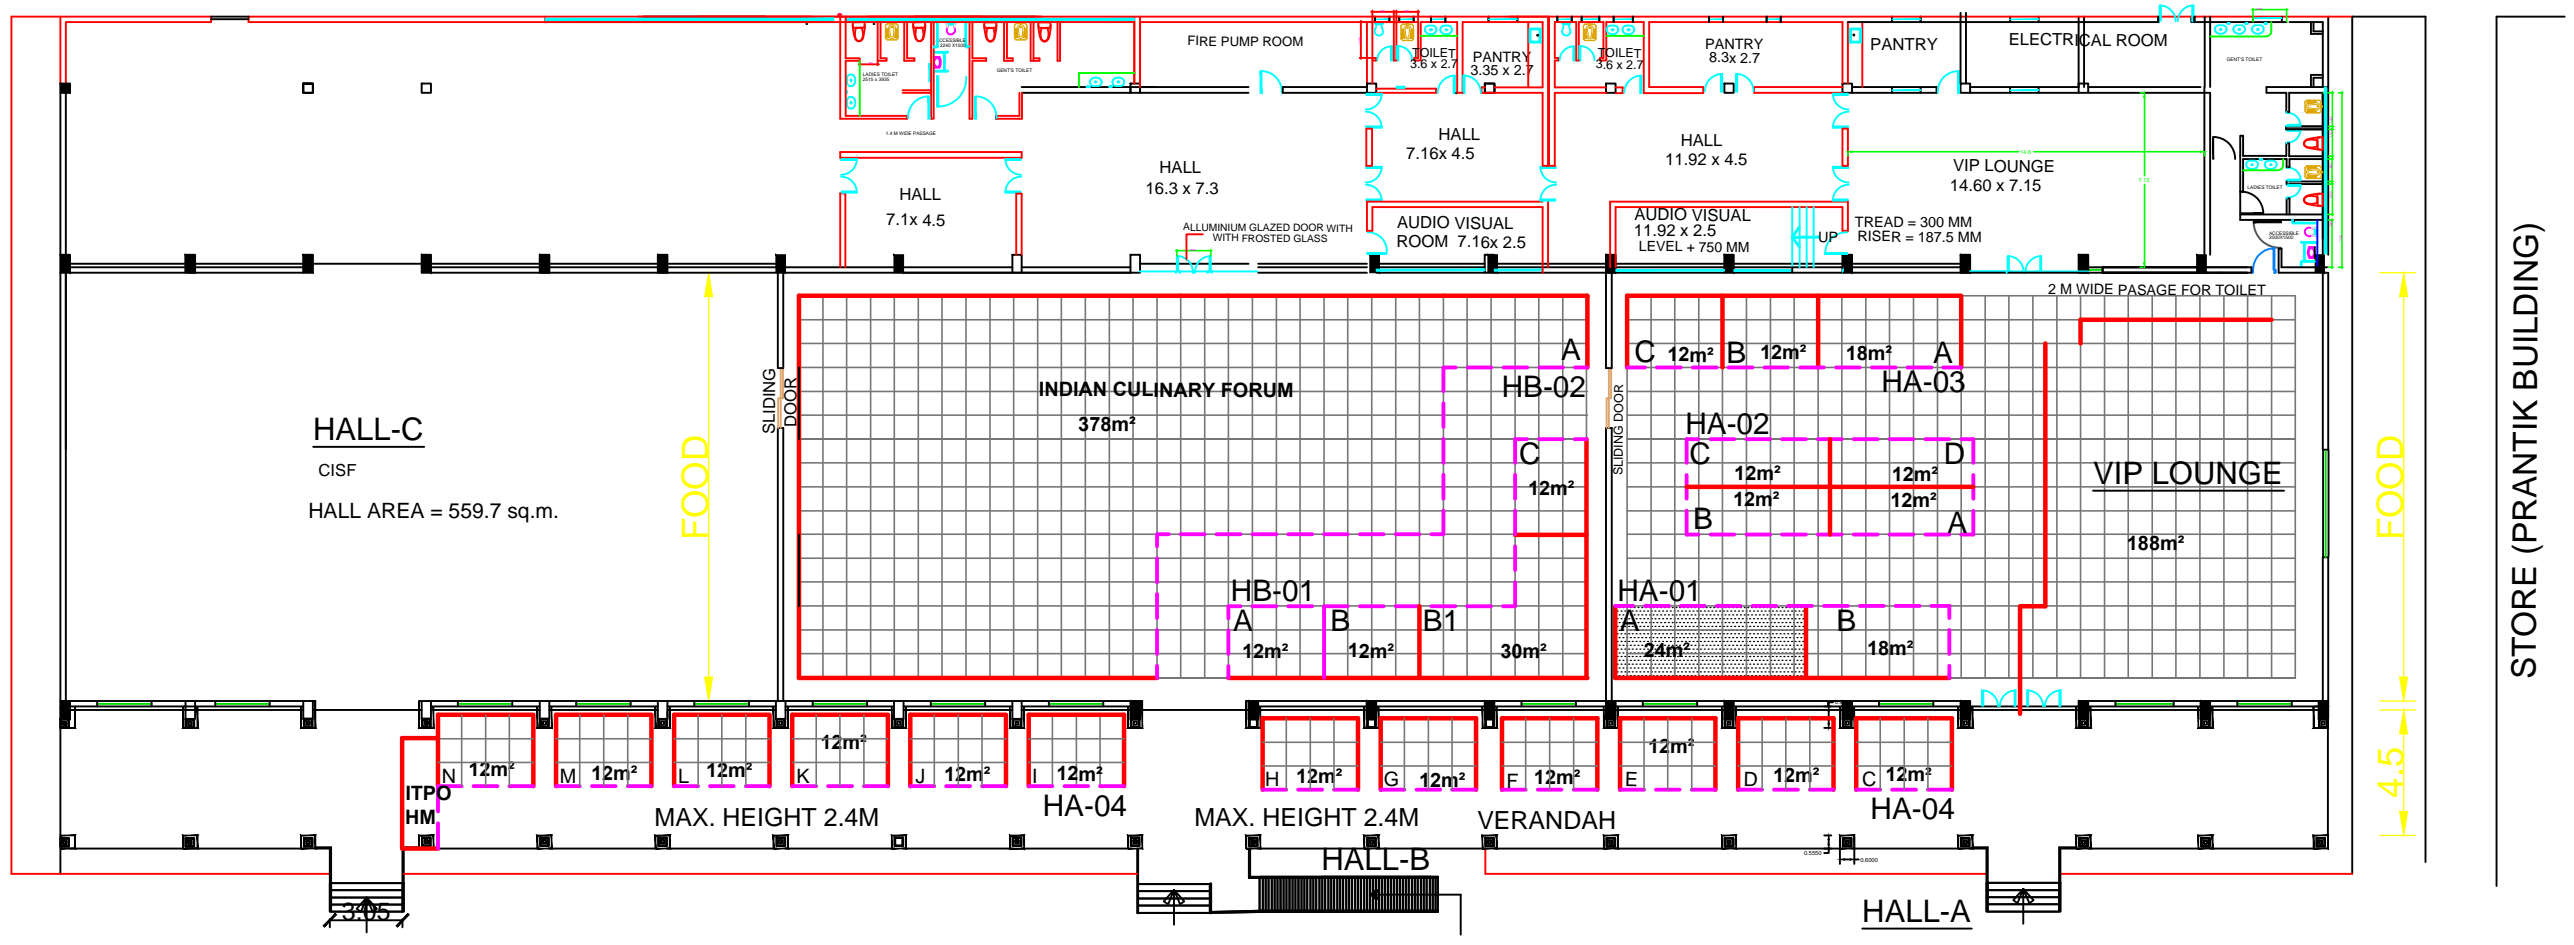

GROUND FLOOR PLAN

NOTE: ALL THE STALLS ARE OF 9 SQ.M. OR AS MENTIONED.




INDIA TRADE PROMOTION ORGANISATION


ARCHITECTURE DEPARTMENT

I T P O

PRAGATI MAIDAN, N. DELHI.

1. FINALISED TO BE UPLOADED ON WEBSITE S. NO. _____ REVISION _____	30.11.2015 DATE
SAURABH SHARMA DT. MANAGER (ARCHITECTURE)	PARMINDER KAUR MANAGER (ARCHITECTURE)
BRJ LAL CH. MANAGER (ARCHITECTURE)	

NORTH: 	DRAWING NO: AAHAR-2019_HABC
SCALE: FIT TO PAPER	DATE: 04.02.2019

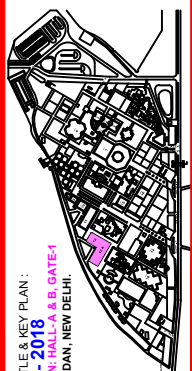

PROJECT TITLE & KEY PLAN : AAHAR - 2019 LAYOUT PLAN: HALL-A & B, GATE-1 PRAGATI MAIDAN, NEW DELHI.